


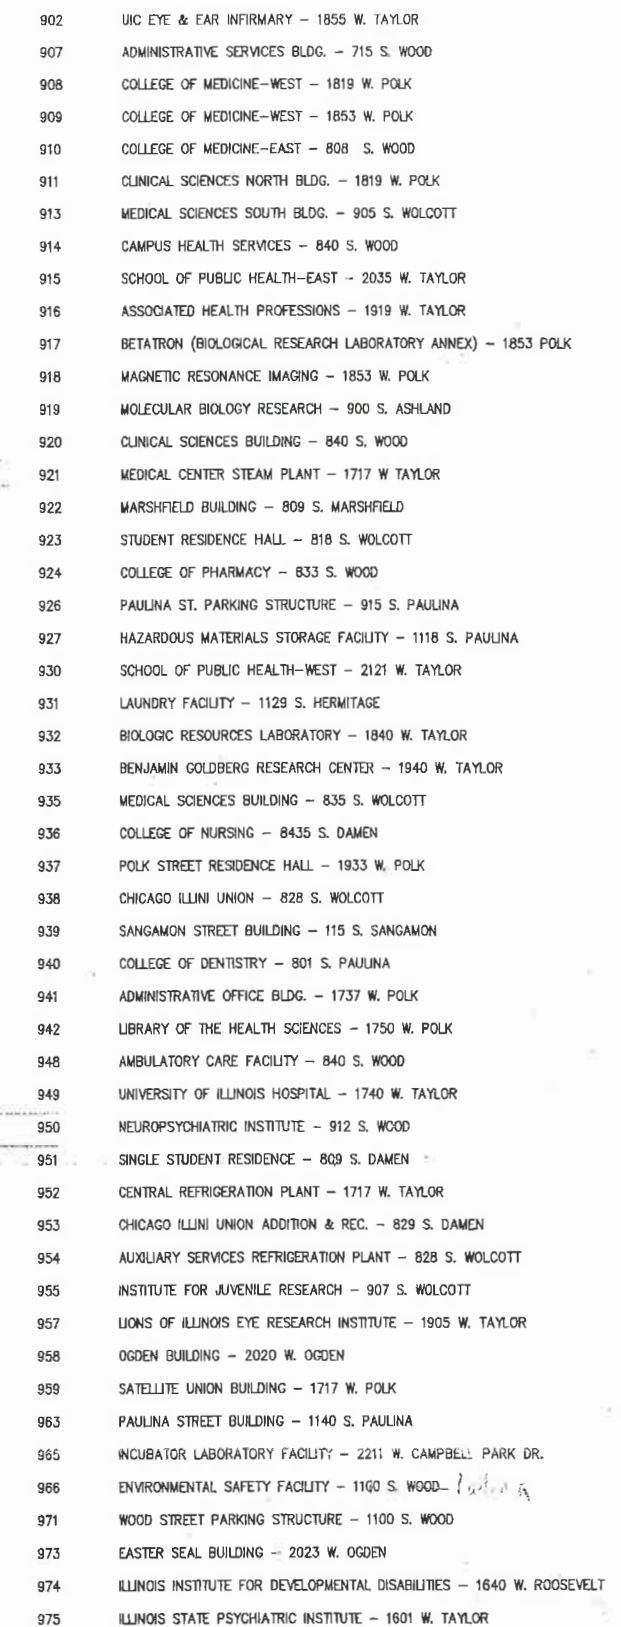

NOTES:

1. THIS SHEET ILLUSTRATES THE EXISTING UNDERGROUND CONDUIT DUCTLINES AND THE EXISTING DISTRIBUTION CENTER AND LOAD CENTERS ON THE WEST CAMPUS. THE CONTRACTOR SHALL BE RESPONSIBLE FOR THE INSTALLATION OF CABLE THROUGH THE EXISTING DUCTLINES FOR INTERCONNECTION OF THE DISTRIBUTION CENTER, THE LOAD CENTERS AND THE SPECIFIED BUILDINGS.
2. SHEETS E-1.# PROVIDE GREATER DETAIL OF THE EXISTING UNDERGROUND DUCTLINES AND MANHOLES. THEY ALSO PROVIDE A DUCTLINE SCHEDULE FOR ROUTING OF THE CABLES.
3. SHEETS E-2.# PROVIDE ONE-LINES AND DETAILS OF THE DISTRIBUTION CENTERS AND LOAD CENTERS.
4. SHEETS E-3.# PROVIDE ONE-LINES AND DETAILS OF THE INDIVIDUAL BUILDINGS.

Load Center
No. 8 - 977


BOARD OF TRUSTEES
UNIVERSITY OF ILLINOIS
C/O PHYSICAL PLANT
PHYSICAL PLANT DEPARTMENT

SITE PLAN - EXISTING ELECTRICAL DUCTLINES - UIC WEST CAMPUS	HRA NO.: 97-1584D
ELECTRICAL DISTRIBUTION DEVELOPMENT - PHASE 1 BID PACKAGE NO. 3 - ELECTRICAL BID PACKAGE WEST CAMPUS ELECTRICAL DISTRIBUTION	DATE: FEBRUARY 10, 1999 SHEET NO.: E-1

REVISIONS			DESIGNED	APPROVED	
NO.	DATE	REMARKS	CEB		
			DRAFTED	APPROVED	
			TDC		
			DESIGNED	APPROVED	

HR **Henneman Raufisen**
AND ASSOCIATES INC
Engineers and Architects
1605 South State Street, Champaign, Illinois 61820-7240

Only Wed Feb 10 10:41:15 1999 Travis Gates

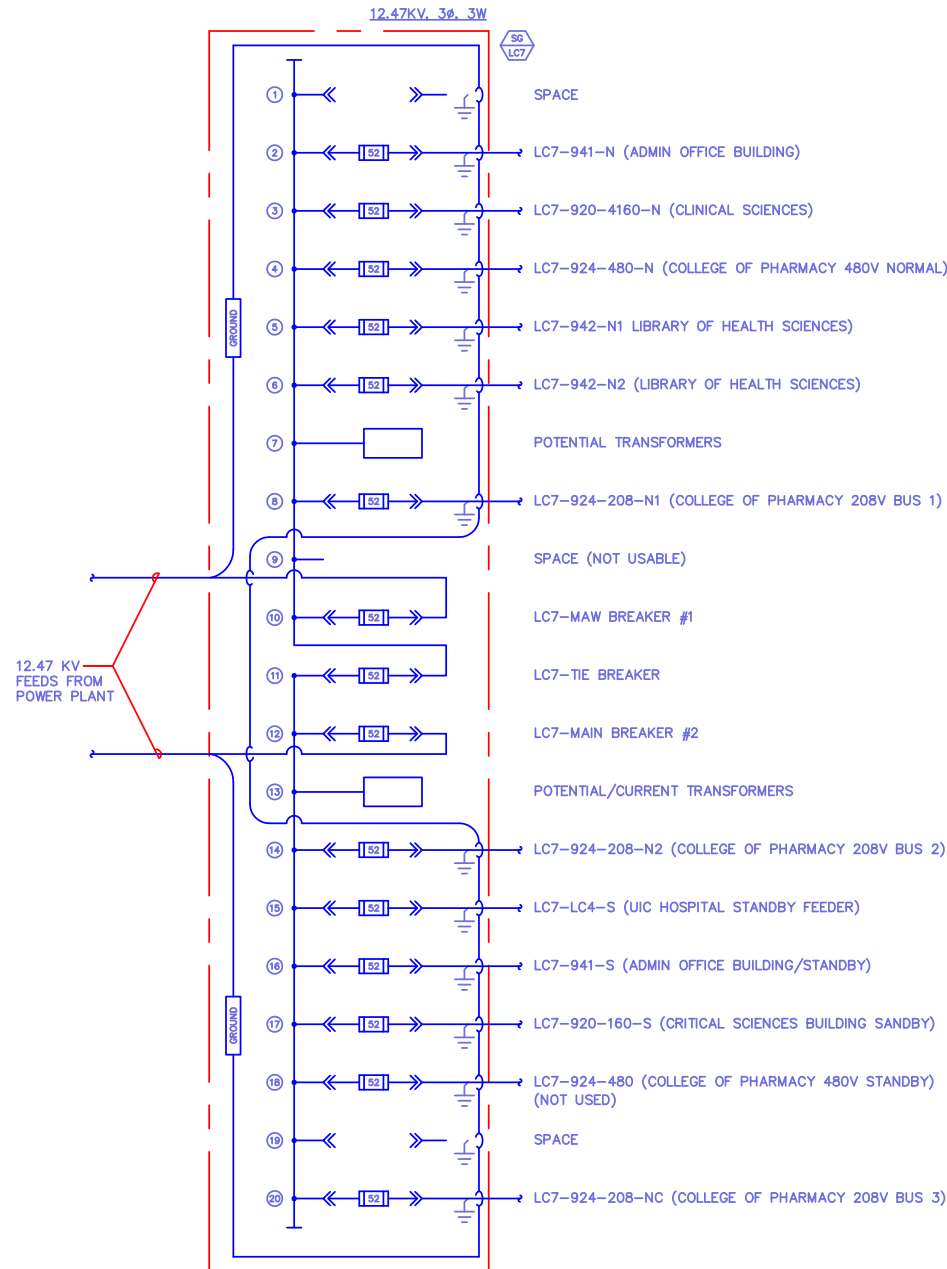

UIC UNIVERSITY OF ILLINOIS
AT CHICAGO

DLA ARCHITECTS

462 North McLean Boulevard | Elgin, Illinois 60123 | Phone 847.742.4063 | Fax 847.742.9734
15 Salt Creek Lane, Suite 400 | Hinsdale, Illinois 60521 | Phone 630.230.0420 | Fax 630.230.0024
www.dla-hd.com info@dlahd.com

ONE-LINE DIAGRAMS 15 KV SWITCHGEAR

COLLEGE OF PHARMACY- UIC
JUNE 8th, 2009

PLATE #:

57